


A SUITE 330 LAYOUT

Scale: 3/16" = 1'-0"

NOTES:
 1-EXISTING BUILDING IS FULLY EQUIPPED WITH AN APPROVED AUTOMATIC FIRE SPRINKLER SYSTEM. EXISTING SYSTEM TO BE MODIFIED UNDER SEPARATE APPLICATION.
 2-EXISTING BUILDING PROVIDES SMOKE DETECTORS THROUGHOUT ALL PUBLIC AREAS.

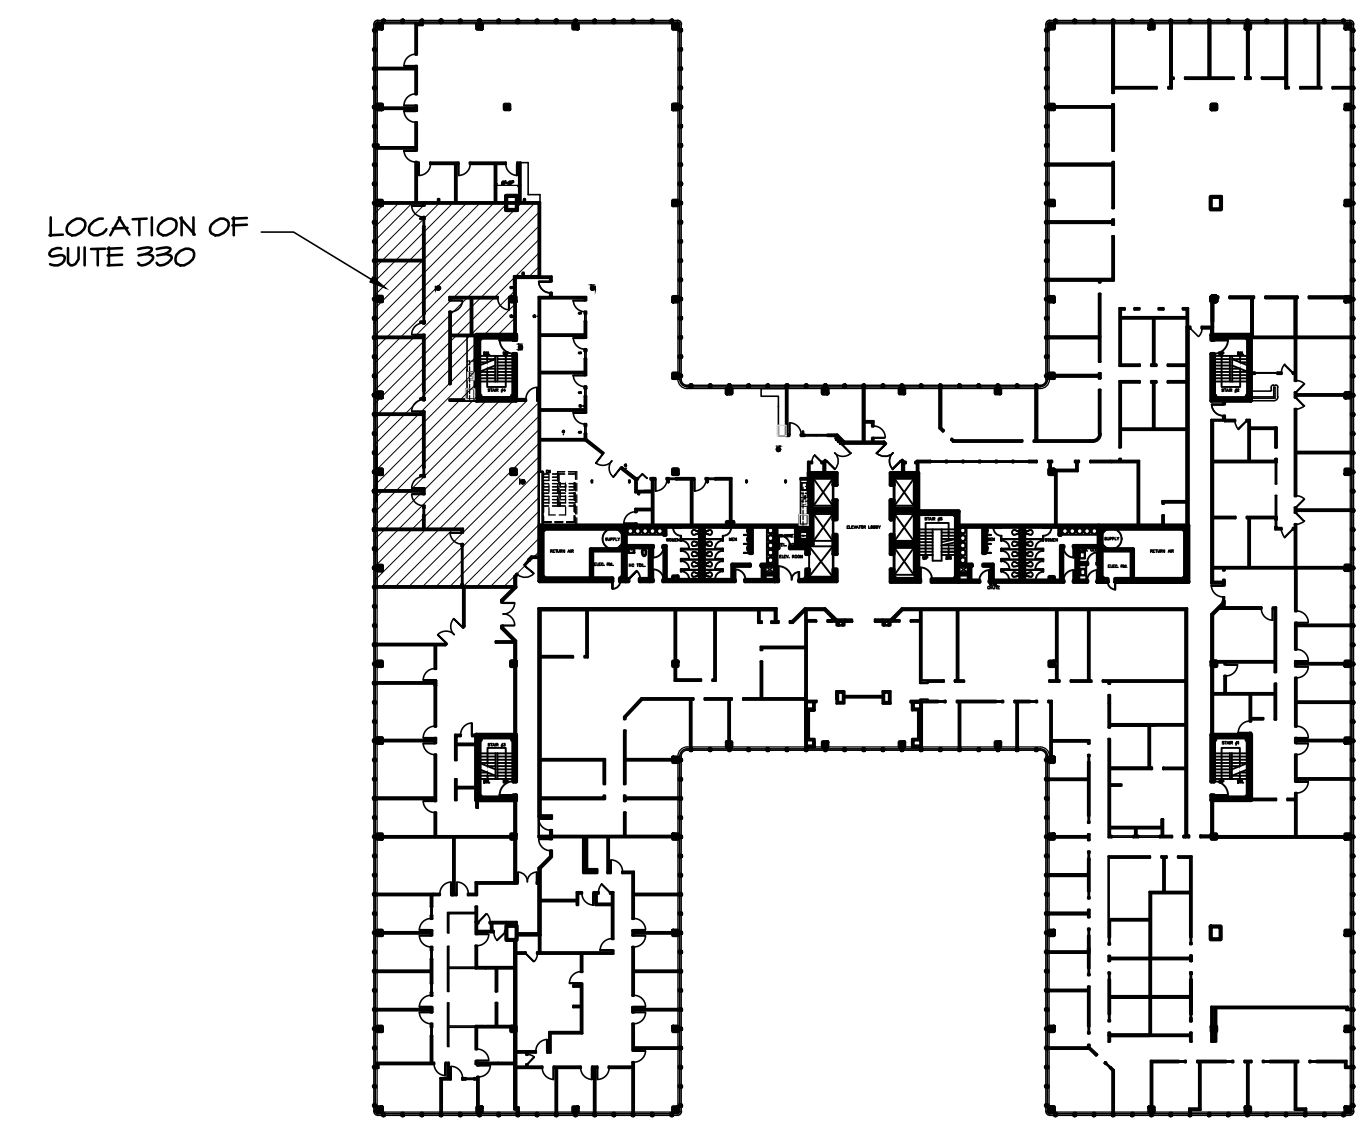

1 THIRD FLOOR SUITE LOCATION PLAN

Scale: N.T.S.

By: _____
 PRINT NAME:
 TITLE:



208 ROUTE 109, SUITE 208, FARMINGDALE, NY 11735
 TEL.: 631-393-6805 FAX: 631-393-6808
 E-MAIL: NCDC @ AOL.COM

ISSUED		
NO.	DATE	REMARKS

REVISIONS		
NO.	DATE	REMARKS
1	7-10-23	REVISED LAYOUT
2	7-11-23	REVISED LAYOUT

THESE PLANS ARE AN INSTRUMENT OF SERVICE AND ARE THE PROPERTY OF THE ARCHITECT. INFRINGEMENTS WILL BE PROSECUTED.
 CONTRACTOR SHALL VERIFY ALL FIELD CONDITIONS AND DIMENSIONS AND BE RESPONSIBLE FOR FIELD FIT AND QUALITY OF WORK. NO ALLOWANCES SHALL BE MADE IN BEHALF OF THE CONTRACTOR FOR ANY ERRORS, OMISSIONS, NOR NEGLECT ON HIS PART.

PROPOSED SUITE LAYOUT FOR:

SUITE 330
445 MELVILLE LLC.
 445 BROADHOLLOW ROAD
 MELVILLE, NEW YORK 11747

DATE: 7-7-23
SCALE: AS NOTED
DRAWN: C.A.S
JOB NO: 2330

THIRD FLOOR-SUITE 330 FLOOR PLAN

DRAWING NO.

A-1.0